





PROPOSED BLOCK SITE PLAN 1:1250

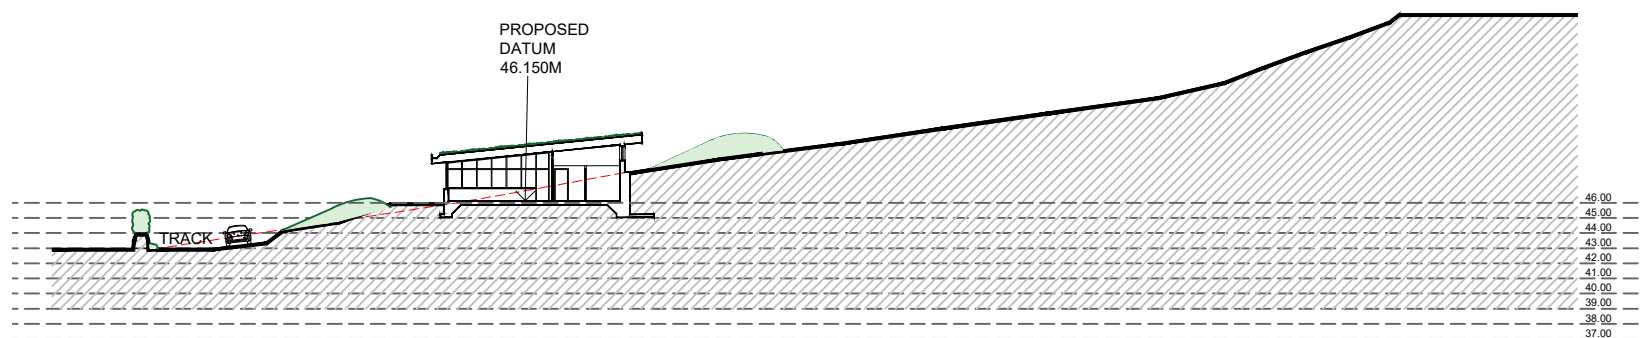

PROPOSED SITE SECTION A-A 1:500

REVISIONS NOTES. © Pembroke Design Ltd 2018		DATE REV	PEMBROKE DESIGN L I M I T E D		
Drwg PROPOSED SITE & SITE SECTION		● HAVERFORDWEST 5/7 PICTON PLACE SA61 2LE TEL: 01437 764135 FAX: 01437 764471 hwest@pembrokedesign.co.uk		○ PEMBROKE DOCK 16 MEYRICK STREET SA72 6UT TEL: 01646 683439 FAX: 01646 681563 pdock@pembrokedesign.co.uk	
Project PROPOSED FIELD CLASSROOM, DRAGON LNG, WATERSTON		Designed .	Scale NOTED	Original Size A3	CHARTERED ARCHITECTS BUILDING SURVEYORS QUANTITY SURVEYORS CDM C O - O R D I N A T O R S
Client DRAGON LTD		Drawn MK	Date NOV 21	Checked by MCW	Job No 9338
					Drwg No Rev P01