
 



PROPOSED EAST ELEVATION 1:100

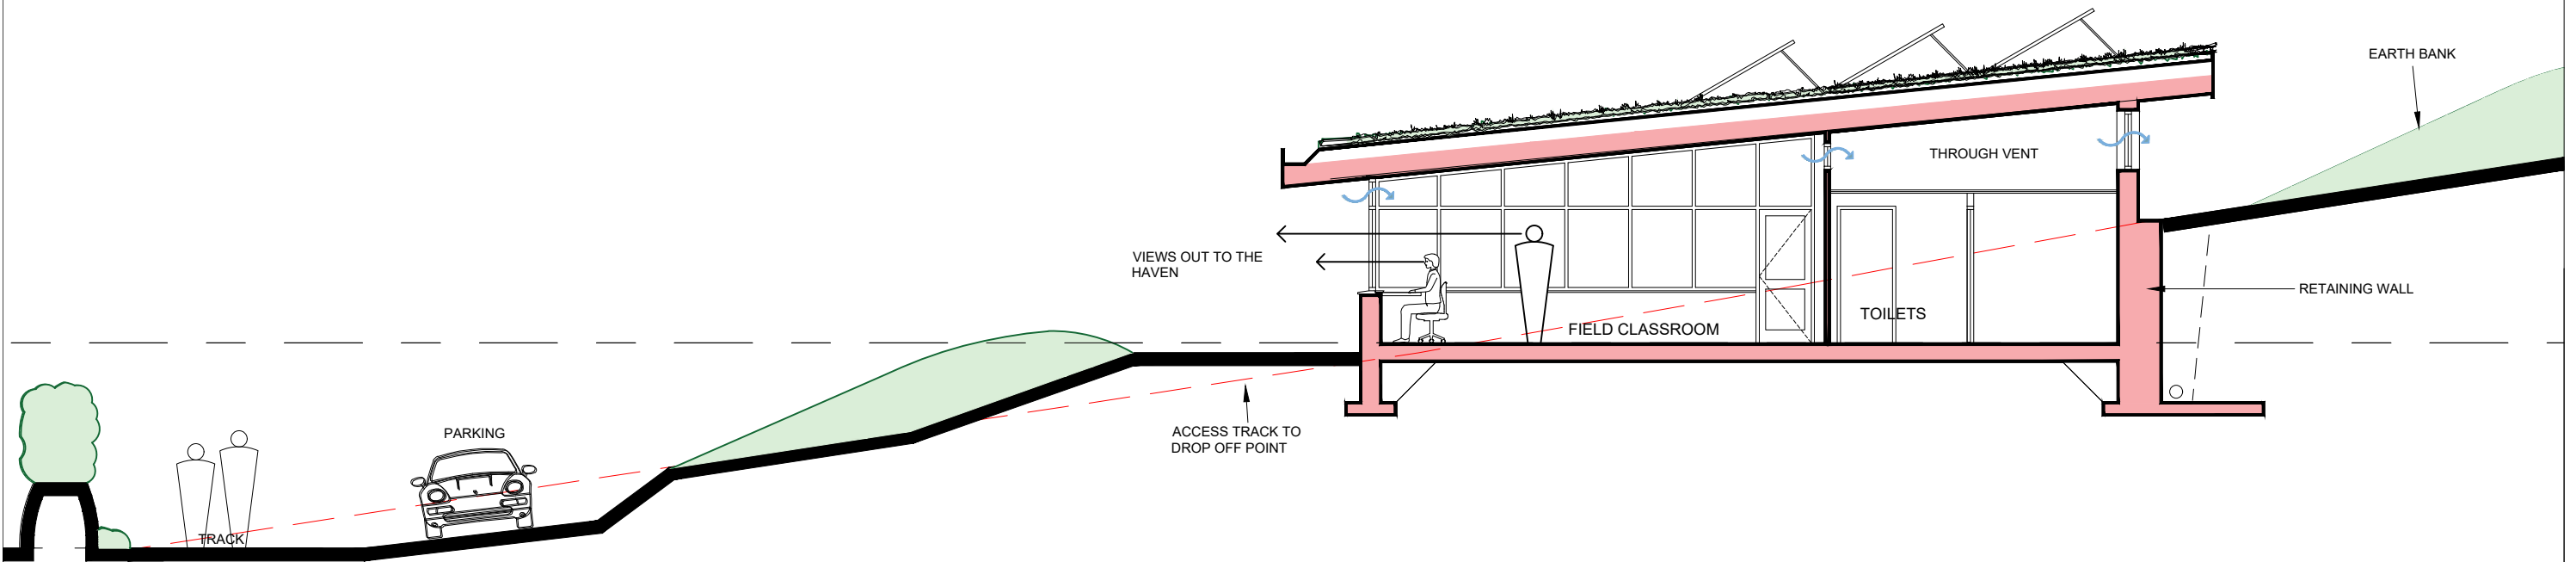

PROPOSED SECTION 1:100



REVISIONS NOTES.		DATE	REV	PEMBROKE DESIGN L I M I T E D			 CHARTERED ARCHITECTS BUILDING SURVEYORS QUANTITY SURVEYORS CDM CO-ORDINATORS
© Pembroke Design Ltd 2018				● HAVERFORDWEST 5/7 PICTON PLACE SA61 2LE TEL: 01437 764135 FAX: 01437 764471 hwest@pembrokedesign.co.uk	○ PEMBROKE DOCK 16 MEYRICK STREET SA72 6UT TEL: 01646 683439 FAX: 01646 681563 pdock@pembrokedesign.co.uk	○ CARMARTHEN 26 SPILMAN STREET SA31 1LQ TEL: 01267 233612 FAX: 01267 233471 carrm@pembrokedesign.co.uk	
Drwg	PROPOSED EAST ELEVATION & SECTION			Designed	Scale	Original Size	Drwg No
Project	PROPOSED FIELD CLASSROOM, DRAGON LNG, WATERSTON			MCW	1:100	A3	Rev
Client	DRAGON LTD			Drawn	Date	Checked by	P04
				MK	NOV 21	MCW	